


2 FOUNDATION PLAN - BASE MODEL
1:50

ELECTRICAL LEGEND

	16 WAY 100AMP PANEL BOX
	220V DUPLEX OUTLET - RANGE
	220V DUPLEX OUTLET - WASHER/DRYER
	220V DUPLEX OUTLET - WATER HEATER
	TELEPHONE JACK
	CABLE TV OUTLET
	110V DUPLEX WALL OUTLET
	GFI DUPLEX WALL OUTLET
	GFI DUPLEX WALL OUTLET - WATER PROOF
	SINGLE POLE SWITCH
	LIGHT FIXTURE
	CEILING FAN LIGHT

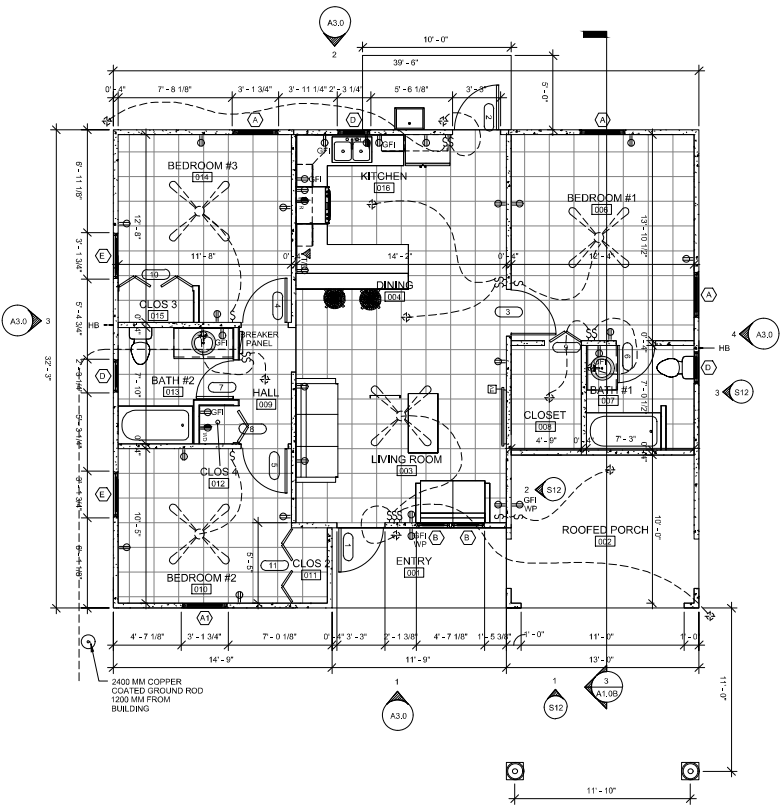

1 FLOOR PLAN - BASE MODEL
1:50

Revisions		
No	Name	Date

TOBY HEIGHTS DEVELOPMENT COMPANY LIMITED
1A-1E BREEMAR AVENUE
KINGSTON 6 JAMAICA, V.I.
Telephone
Facsimile

PHASE: PHASE 2

TOBY HEIGHTS PHASE 2
TOBY HAMMOCKS
LOCATED AT SANDY BAY
CLARENDON

DRAWING NAME:
FOUNDATION & FLOOR
PLAN - BASE MODEL

SUBMISSION DRAWING FOR APPROVAL

JOB #: Project Number FILE:
© 2023 TOBY HEIGHTS DEVELOPMENT COMPANY LIMITED

DRAWN BY: H.M. DATE: JANUARY 2023
CHECKED BY: RI SCALE: As indicated

SHEET:
A1.0A